


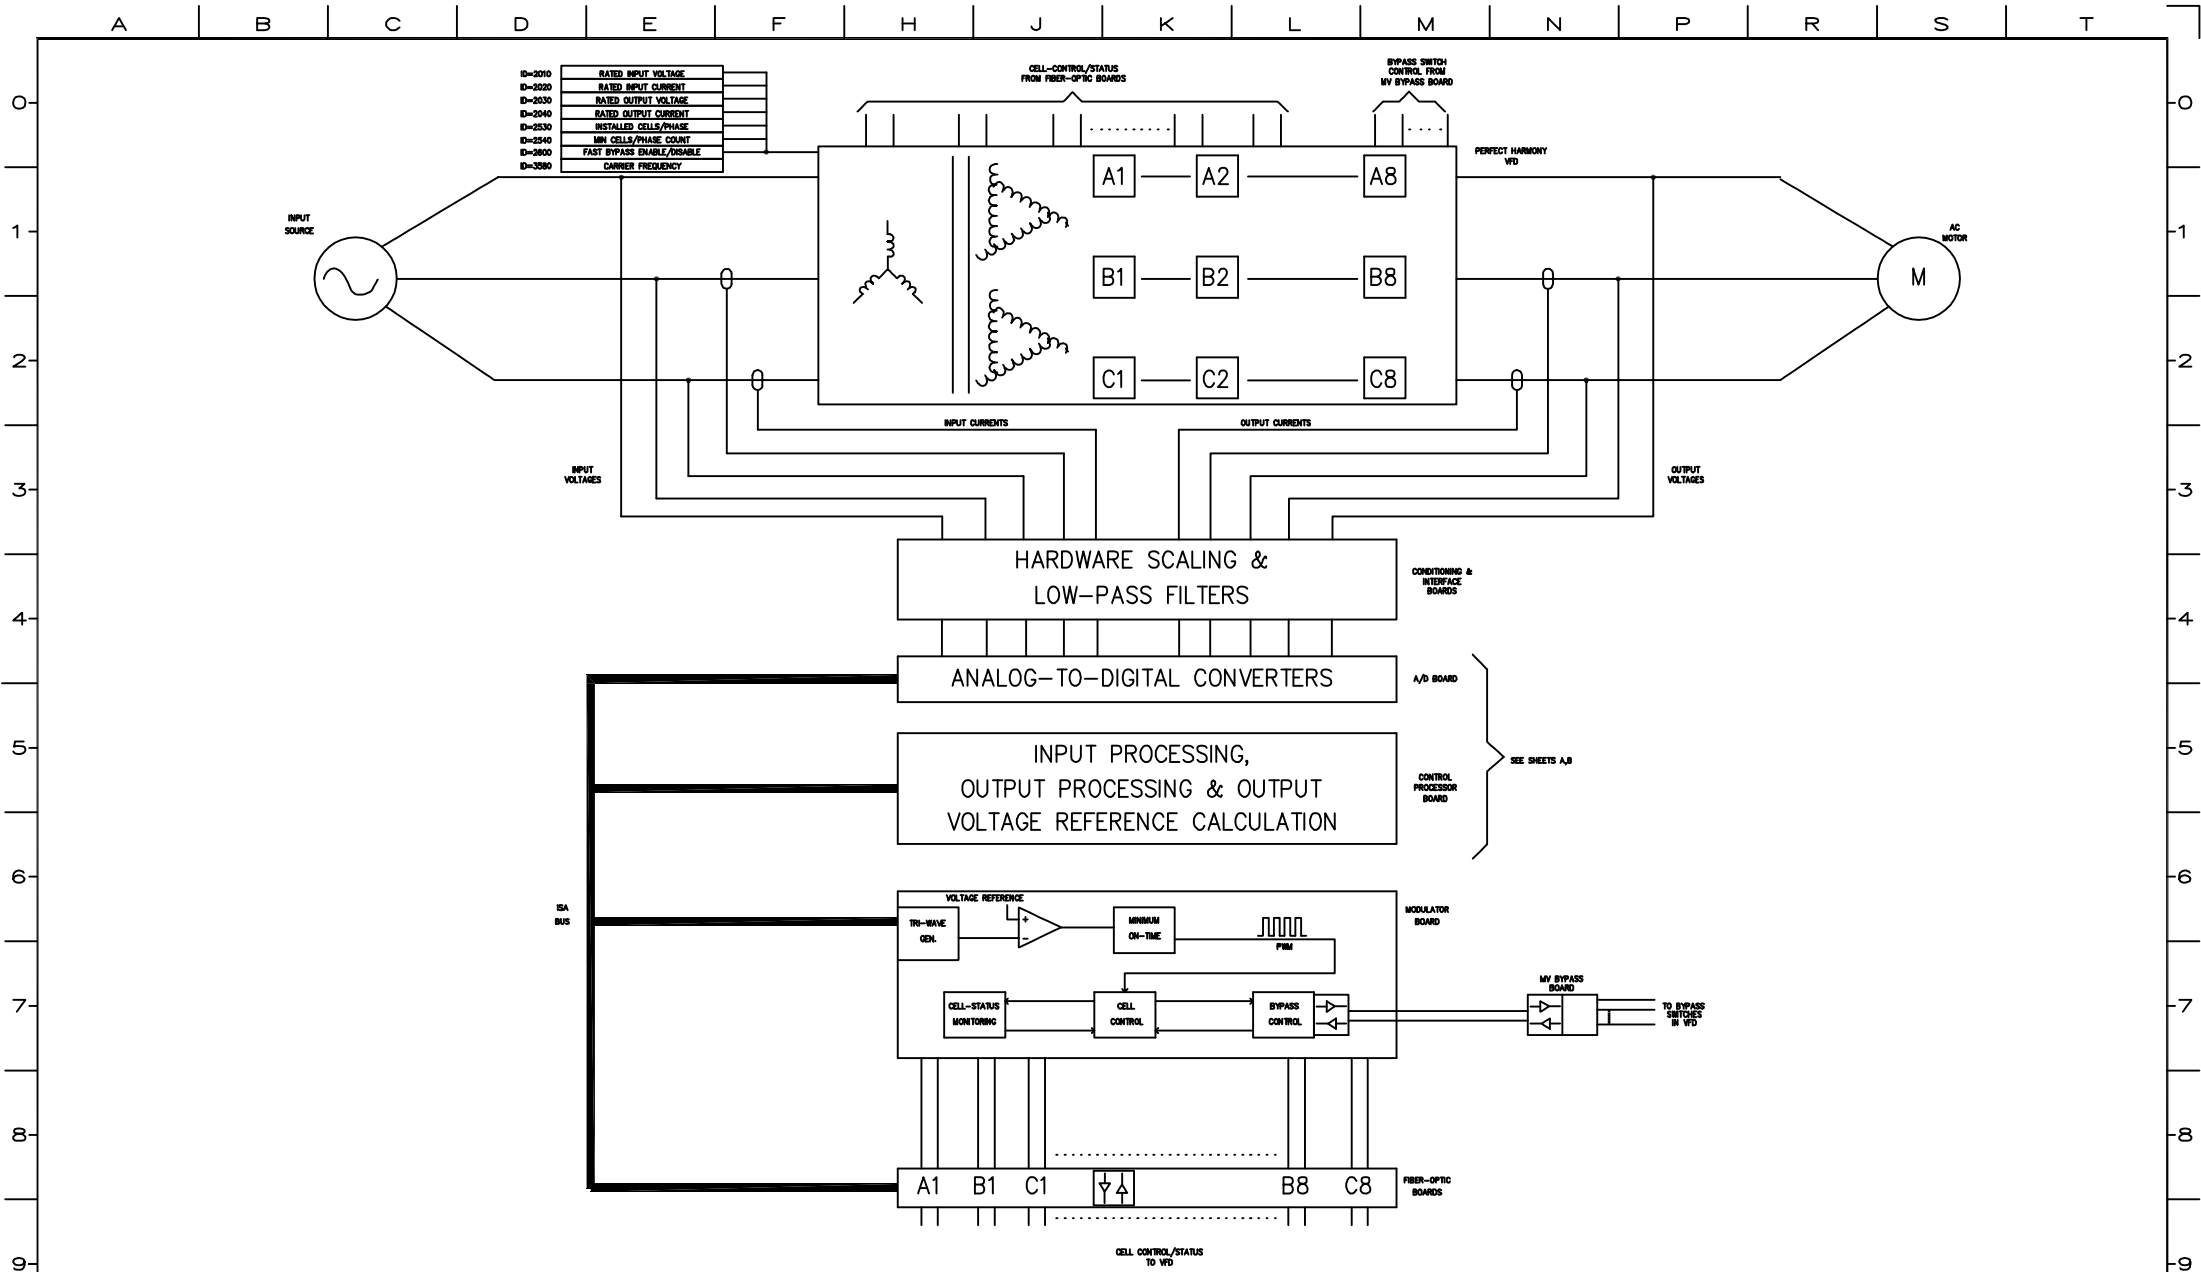


REVISIONS	DATE	05/08/01	THIS DRAWING AND ALL INFORMATION CONTAINED HEREIN IS THE PROPERTY OF ROBICON, AND MAY NOT BE COPIED, REPRODUCED, OR TRANSMITTED IN ANY FORM OR BY ANY MEANS, WITHOUT THE EXPRESS WRITTEN CONSENT OF ROBICON. IT IS PROVIDED SOLELY FOR THE CONVENIENCE OF THE USER AND SHALL BE RETURNED UPON REQUEST. ©1997 ROBICON ALL RIGHTS RESERVED.	UNLESS OTHERWISE SPECIFIED: ALL DIMENSIONS IN INCHES INTERPRET DRAWING PER ASME Y14.5M-1994 TOLERANCES: .XX ± .03 XXX ± .015 ANGLES ± 1° THIRD ANGLE PROJECTION	SCALE	1:1	ROBICON A SUBSIDIARY OF HIGH VOLTAGE ENGINEERING CORP. 800 Hunt Valley Drive, Hunt Valley, PA 15880	TITLE	CONTROL DIAGRAM
	DRAWN BY	A. RIBNICKY			DWG NO	459712		REV	-
	CHECKED BY	J. BUCKEY			CAD FILE	459712-1		SHEET NO	1 OF 1
	DATE	05/08/01			BY	A. RIBNICKY		FOR	J. BUCKEY

SWITCH PRIORITY AND EVALUATION


NOTE 1:
EACH SIMILAR GROUPING OF SWITCHES IS LABELED WITH A TWO LETTER DESIGNATION IDENTIFYING ITS GROUP, PLUS A NUMBER DESIGNATING ITS PRIORITY IN WHICH A LOWER NUMBER HAS LESS PRIORITY OVER A HIGHER NUMBER WITHIN THE GROUPING.

NOTE 2:
DEFAULT VALUES WHEN NO SWITCHES ARE ASSIGNED WITHIN A GROUPING RESULT IN A VALUE OF ZERO UNLESS OTHERWISE NOTED.

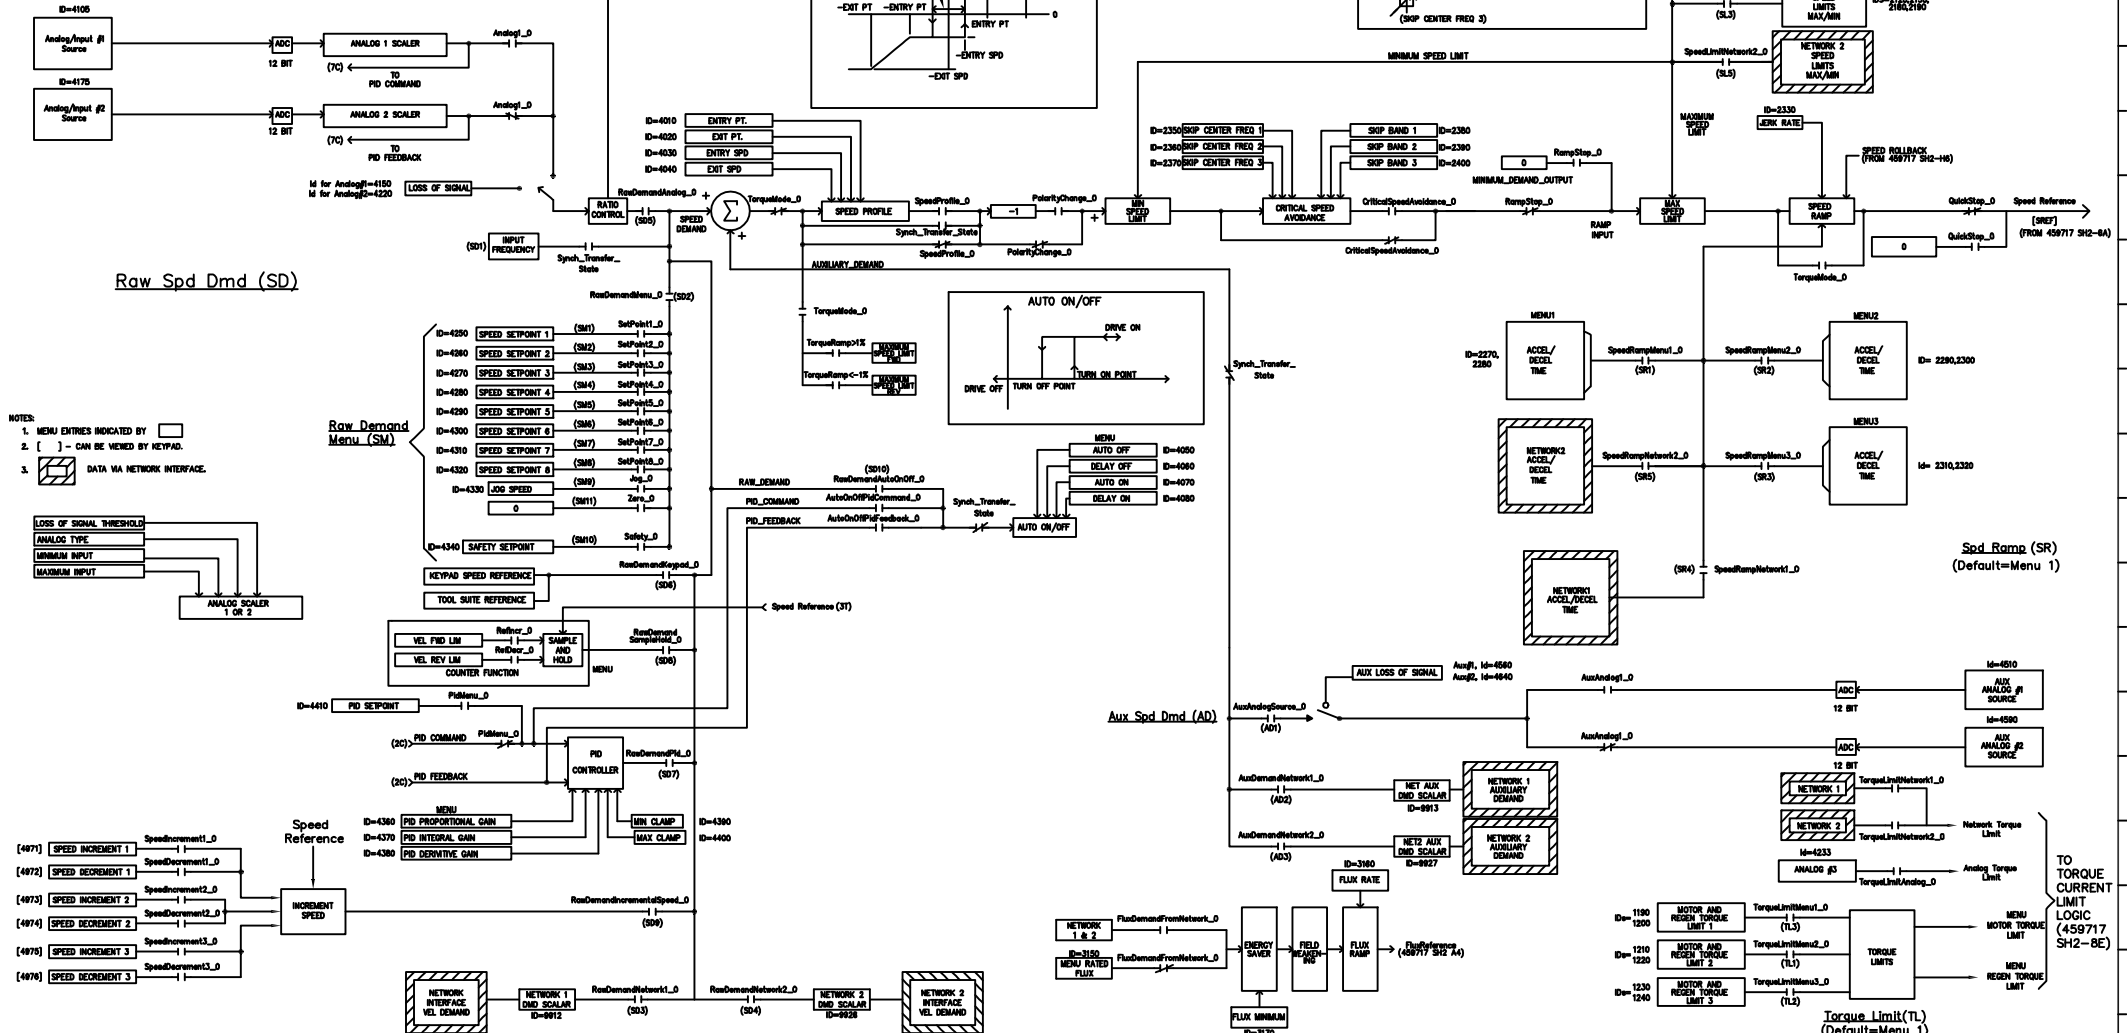

REV	NO.	DATE	DESCRIPTION
001	07945	08/15/94	INITIAL DESIGN
002	08159	08/15/94	REVISION 1
003	08418	08/15/94	REVISION 2
004	08456	08/15/94	REVISION 3
005	08744	08/15/94	REVISION 4
006	09143	08/15/94	REVISION 5
007	11907	08/15/94	REVISION 6
008	79851143	08/15/94	REVISION 7
009	79891715	08/15/94	REVISION 8

THIS DRAWING AND ALL INFORMATION CONTAINED HEREIN IS THE PROPERTY OF SIEMENS DRIVE SYSTEMS, INC. AND MAY NOT BE COPIED, REPRODUCED, OR DISCLOSED TO UNAUTHORIZED PERSONS WITHOUT THE EXPRESS WRITTEN CONSENT OF SIEMENS DRIVE SYSTEMS, INC. IT IS PROVIDED SOLELY FOR THE CONVENIENCE OF THE USER AND SHALL BE RETURNED UPON REQUEST. © 2008 SIEMENS ALL RIGHTS RESERVED	UNLESS OTHERWISE SPECIFIED, ALL DIMENSIONS IN INCHES INTERPRET DRAWING PER ASME Y14.5M-1994 TOLERANCES: .XX ± .03 ANGLES ± 1° THIRD ANGLE PROJECTION	DATE: 05/08/01 DRAWN BY: J. BUCKLEY CHECKED BY: J. BUCKLEY	SIEMENS Energy and Automation, Inc. Large Drives - A	TITLE: COMMAND GENERATOR DIAGRAM DWG NO: A1A459713 REV: 1 OF 1
--	---	---	--	---

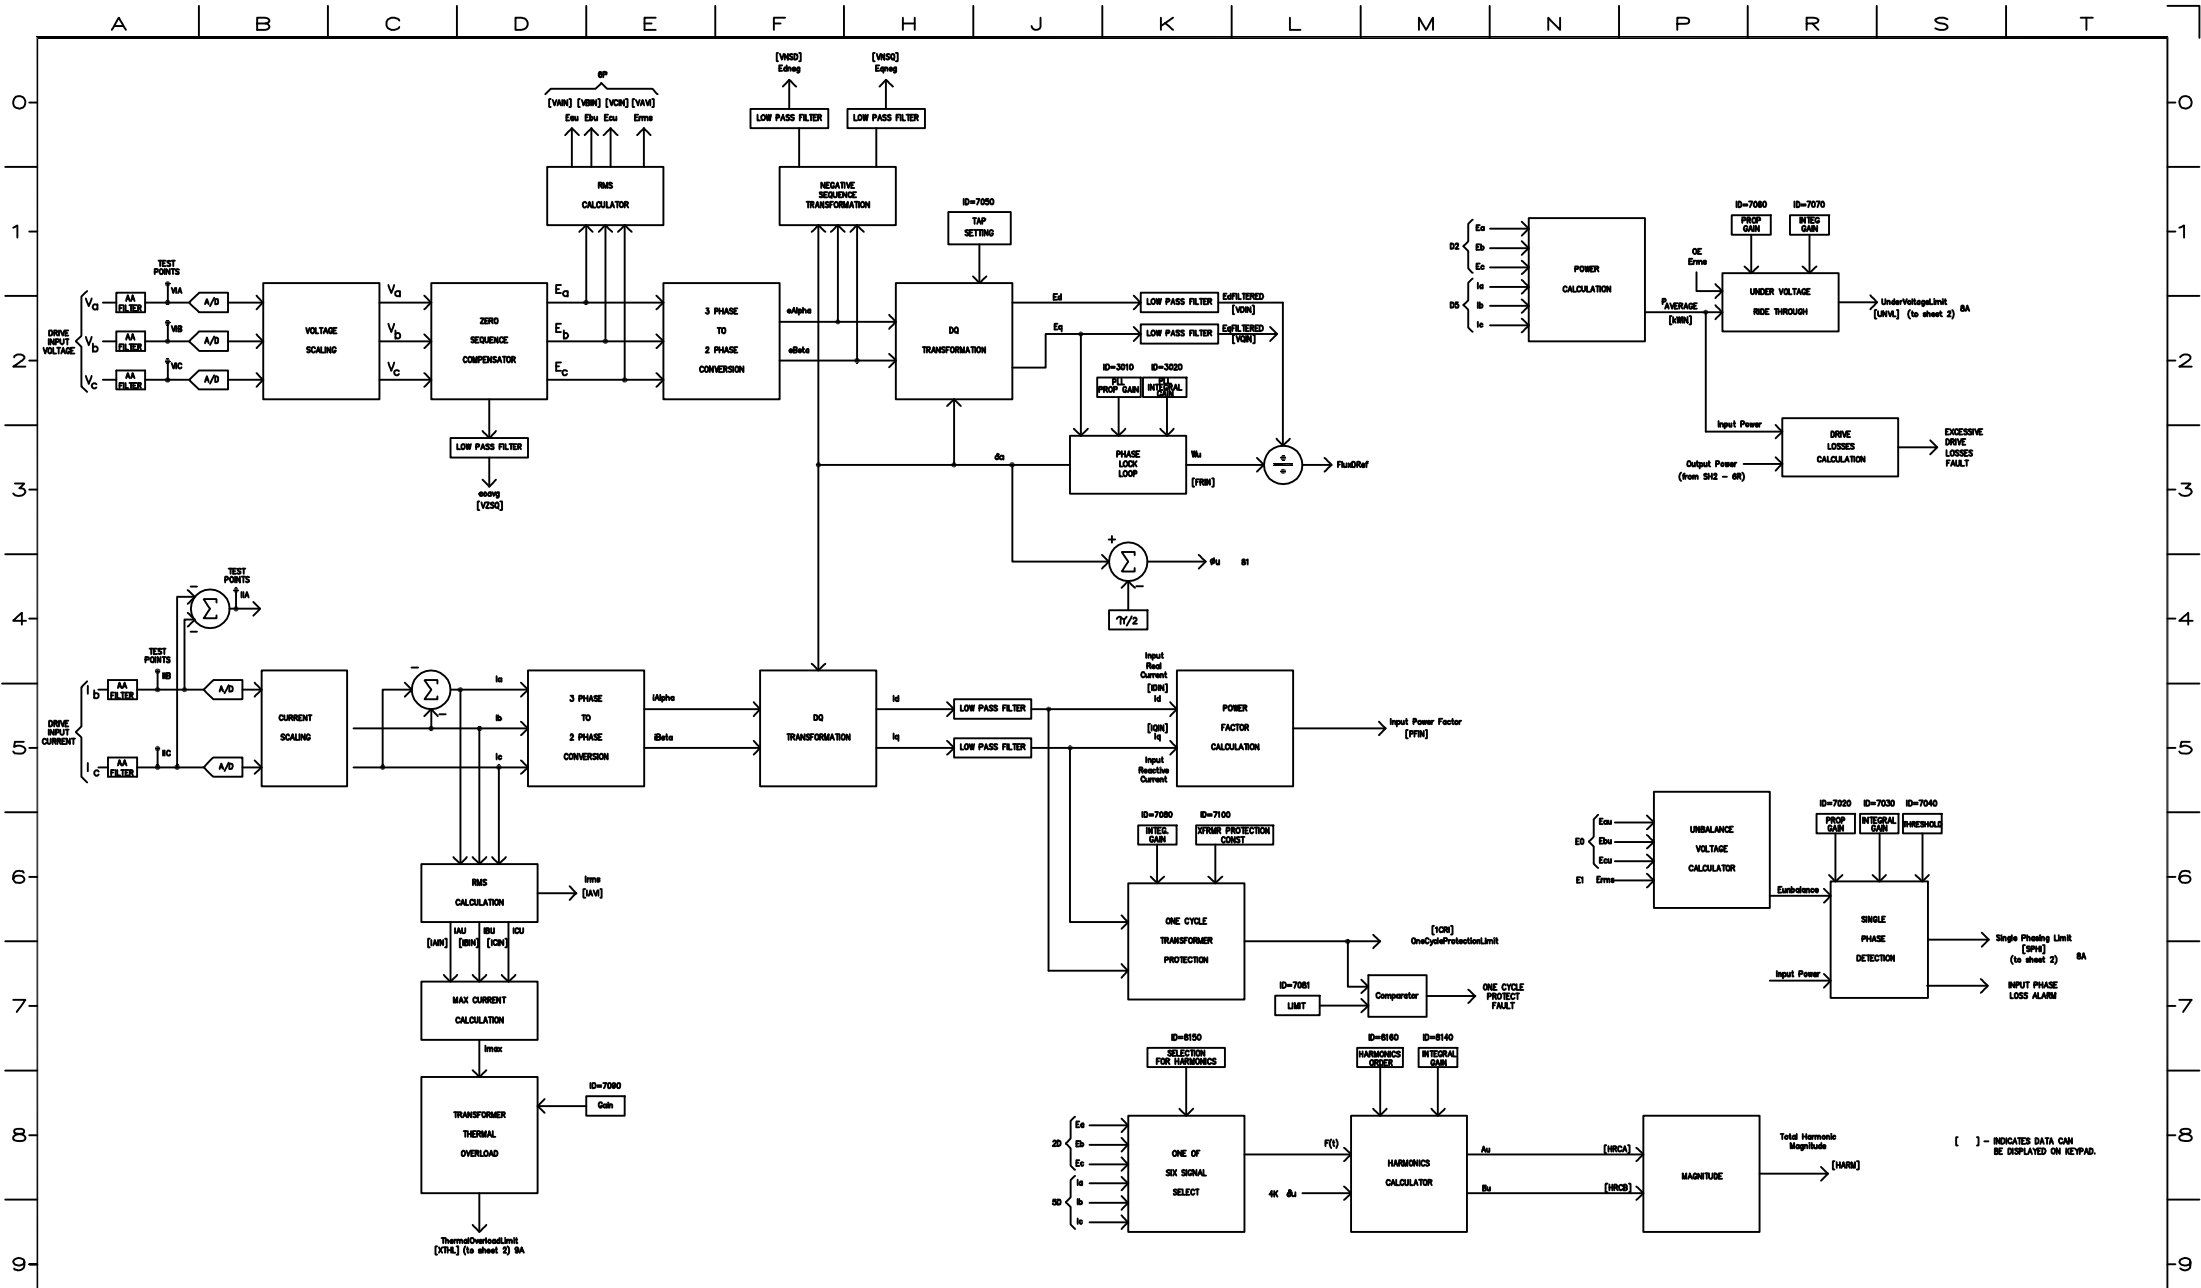

REV	NO.	DATE	DESCRIPTION
A	08418	08/15/02	GENERAL REVISE
B	08745	07/17/02	GENERAL REVISE
C	11907	07/17/02	GENERAL REVISE
D	79891715	07/17/02	GENERAL REVISE

THIS DRAWING AND ALL INFORMATION CONTAINED HEREIN IS THE PROPERTY OF SIEMENS LARGE DRIVES, INC. AND MAY NOT BE COPIED, REPRODUCED OR DIVULGED TO UNAUTHORIZED PERSONS WITHOUT THE EXPRESS WRITTEN CONSENT OF SIEMENS LARGE DRIVES, INC. IT IS PROVIDED SPECIALLY FOR THE CONVENIENCE OF THE USER AND SHALL BE RETURNED UPON REQUEST. © 2008 SIEMENS ALL RIGHTS RESERVED.		UNLESS OTHERWISE SPECIFIED: ALL DIMENSIONS IN INCHES. INTERPRET DRAWING PER ASME Y14.5M-1994. TOLERANCES: JOG ± .03. JOG ± .015. ANGLES ± 1°.		SCALE: 1:1 LAYER: XXXX DATE: 05/15/01 DRAWN BY: J. BUCKEY CHECKED BY: A. RIBNICKY APPROVED BY: J. BUCKEY	SIEMENS Energy and Automation, Inc. Large Drives - A		TITLE: INPUT PROCESS DIAGRAM DWG NO: A1A459717 REV: BD SHEET NO: 1 OF 2
--	--	---	--	---	--	--	--

